


- NOTES:
1. CAT6A FOR ALL WAPS
 2. CAT6 FOR ALL OTHER DROPS
 3. INSTALL 12 STRAND OM3 MM BACKBONE FIBER BETWEEN ROOMS 119 AND 109

HISTORY AND REVISIONS	
DATE	BY DESCRIPTION

ESU-13 OFFICE ADDITION - SIDNEY
 WESTERN NEBRASKA
 COMMUNITY COLLEGE
 371 COLLEGE DRIVE
 SIDNEY, NE

SHEET TITLE
 FLOOR PLAN

SHEET NUMBER	
1	1

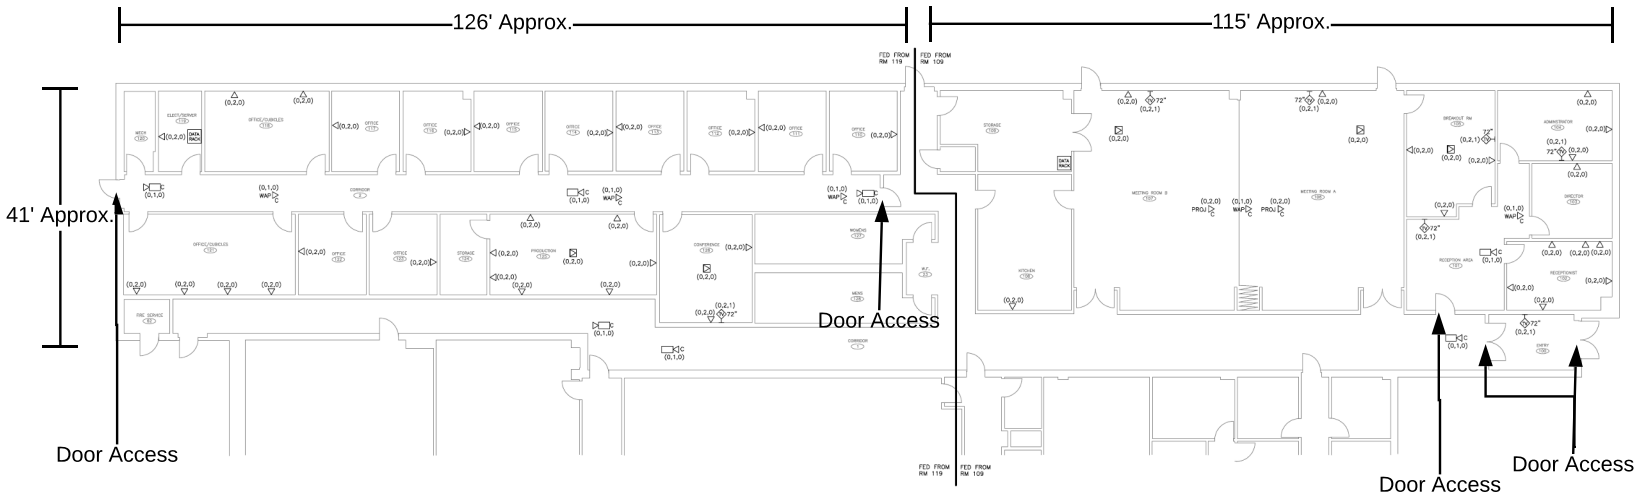

Cable Drop Detail - Main Level
 SCALE: 1/8" = 1'